



<p>NOTES</p> <p>1) This drawing is for illustration purposes only and is subject to change without notice. TIC is not responsible for any errors or omissions.</p>	<p>Drawn by EKM Date 6/04/08 Approved by</p>	<p>TOSHIBA INTERNATIONAL CORPORATION Houston Texas, USA</p> <p>THIS MATERIAL IS THE EXCLUSIVE PROPERTY OF TOSHIBA INTERNATIONAL CORPORATION AND SHALL NOT BE REPRODUCED, USED, OR DISCLOSED TO OTHERS UNLESS PRIOR WRITTEN AUTHORIZATION IS OBTAINED.</p>	<p>TITLE One-Line Diagram 750 kVA G8000MM Series UPS 480V Single Input, 480Y/277V Output</p> <p>DRAWING NO. T8MS3K75KK6XSN</p> <p>REV. 0.0</p>
---	--	--	---

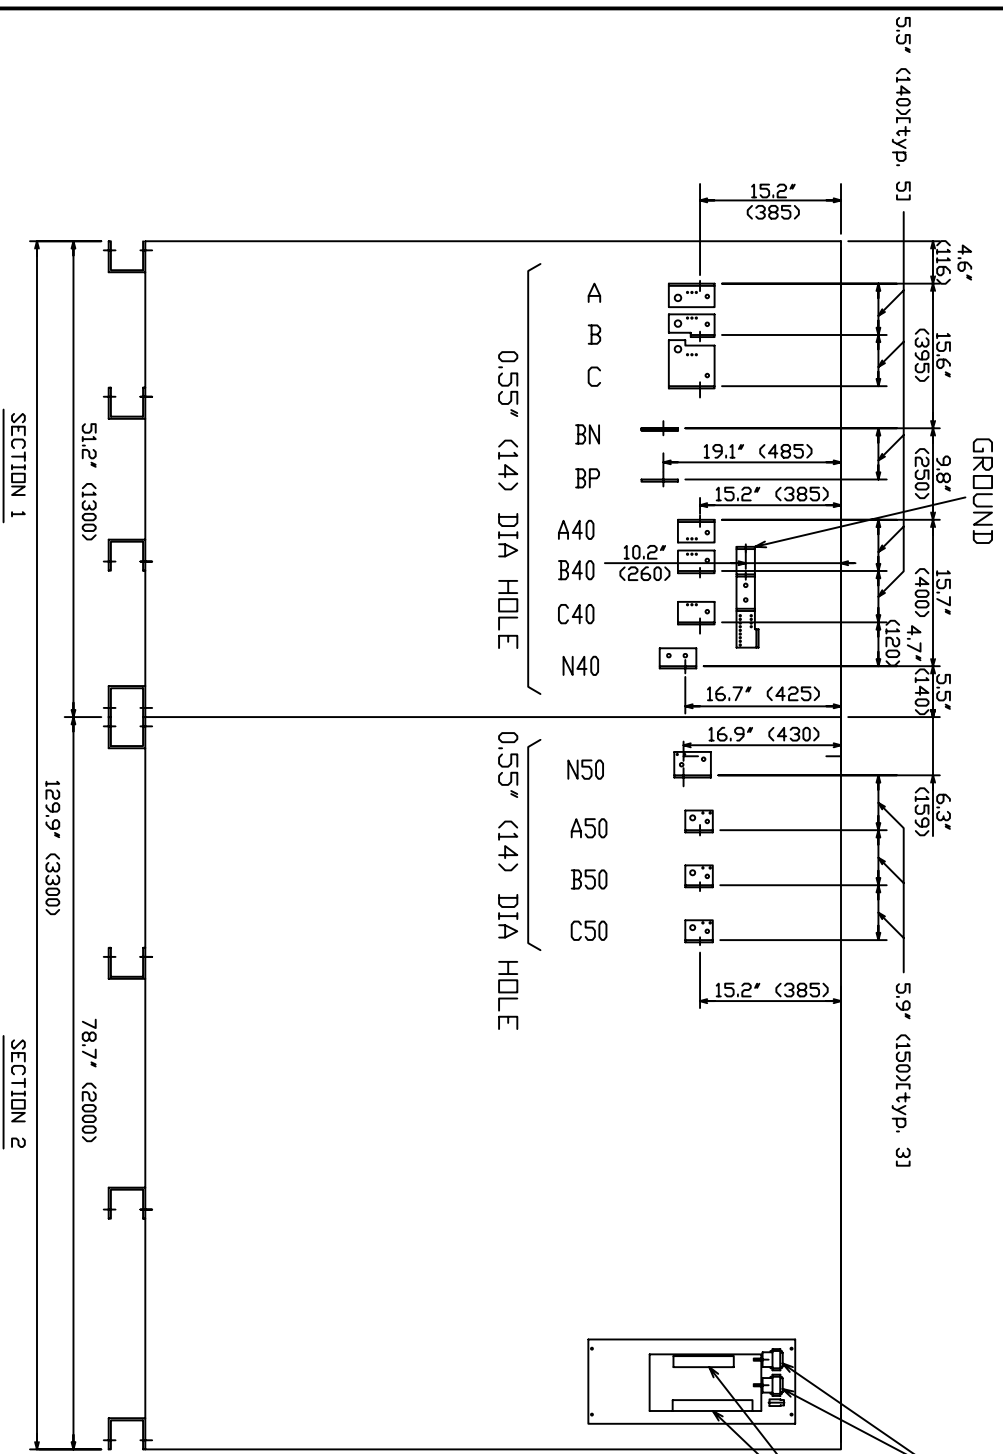

SECTION A-A

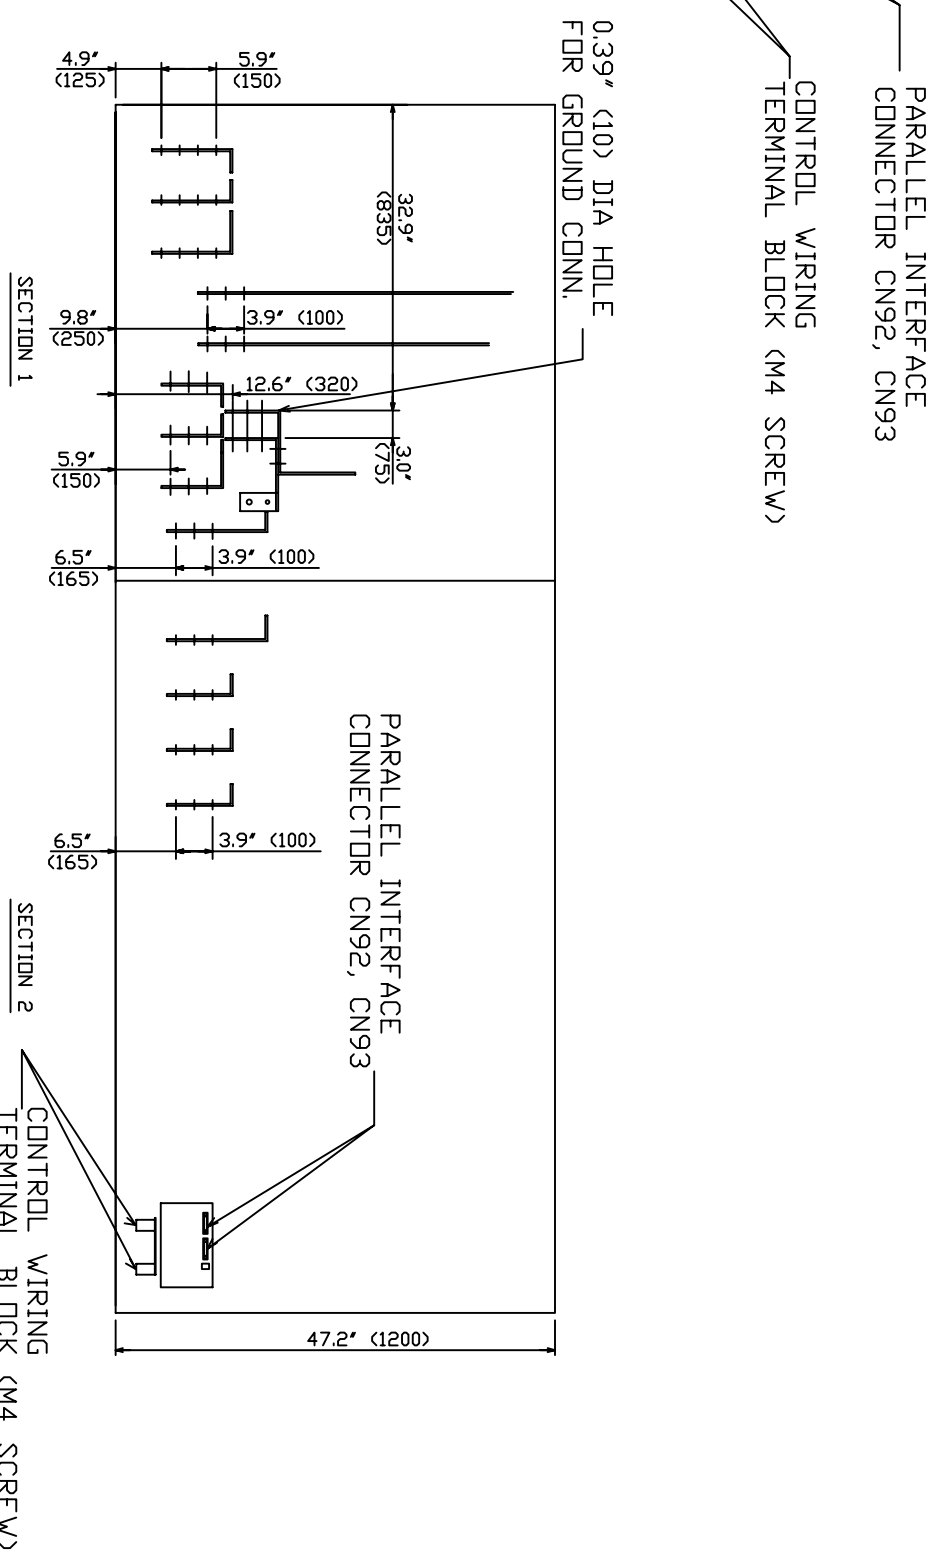

SECTION B-B

INIT RELEASE	P0	JBT	DRAWN BY: JBT	DATE 8/27/07
			CHECKED BY	DATE
			APPROVED BY	DATE

THIS MATERIAL IS THE EXCLUSIVE PROPERTY OF TOSHIBA INTERNATIONAL CORPORATION AND SHALL NOT BE REPRODUCED, USED OR DISCLOSED TO OTHERS UNLESS PRIOR WRITTEN AUTHORIZATION IS OBTAINED.

TITLE: G8000MM UPS 750KVA
OUTLINE & INSTALLATION DRAWING

TOSHIBA INTERNATIONAL CORPORATION
13131 WEST LITTLE YORK ROAD, HOUSTON, TX, 77041 U.S.A.

SCALE	ORDER NO.
NTS	
DRAWING NO.	
75440L22-MKTG	
SH. 2	OF 2